



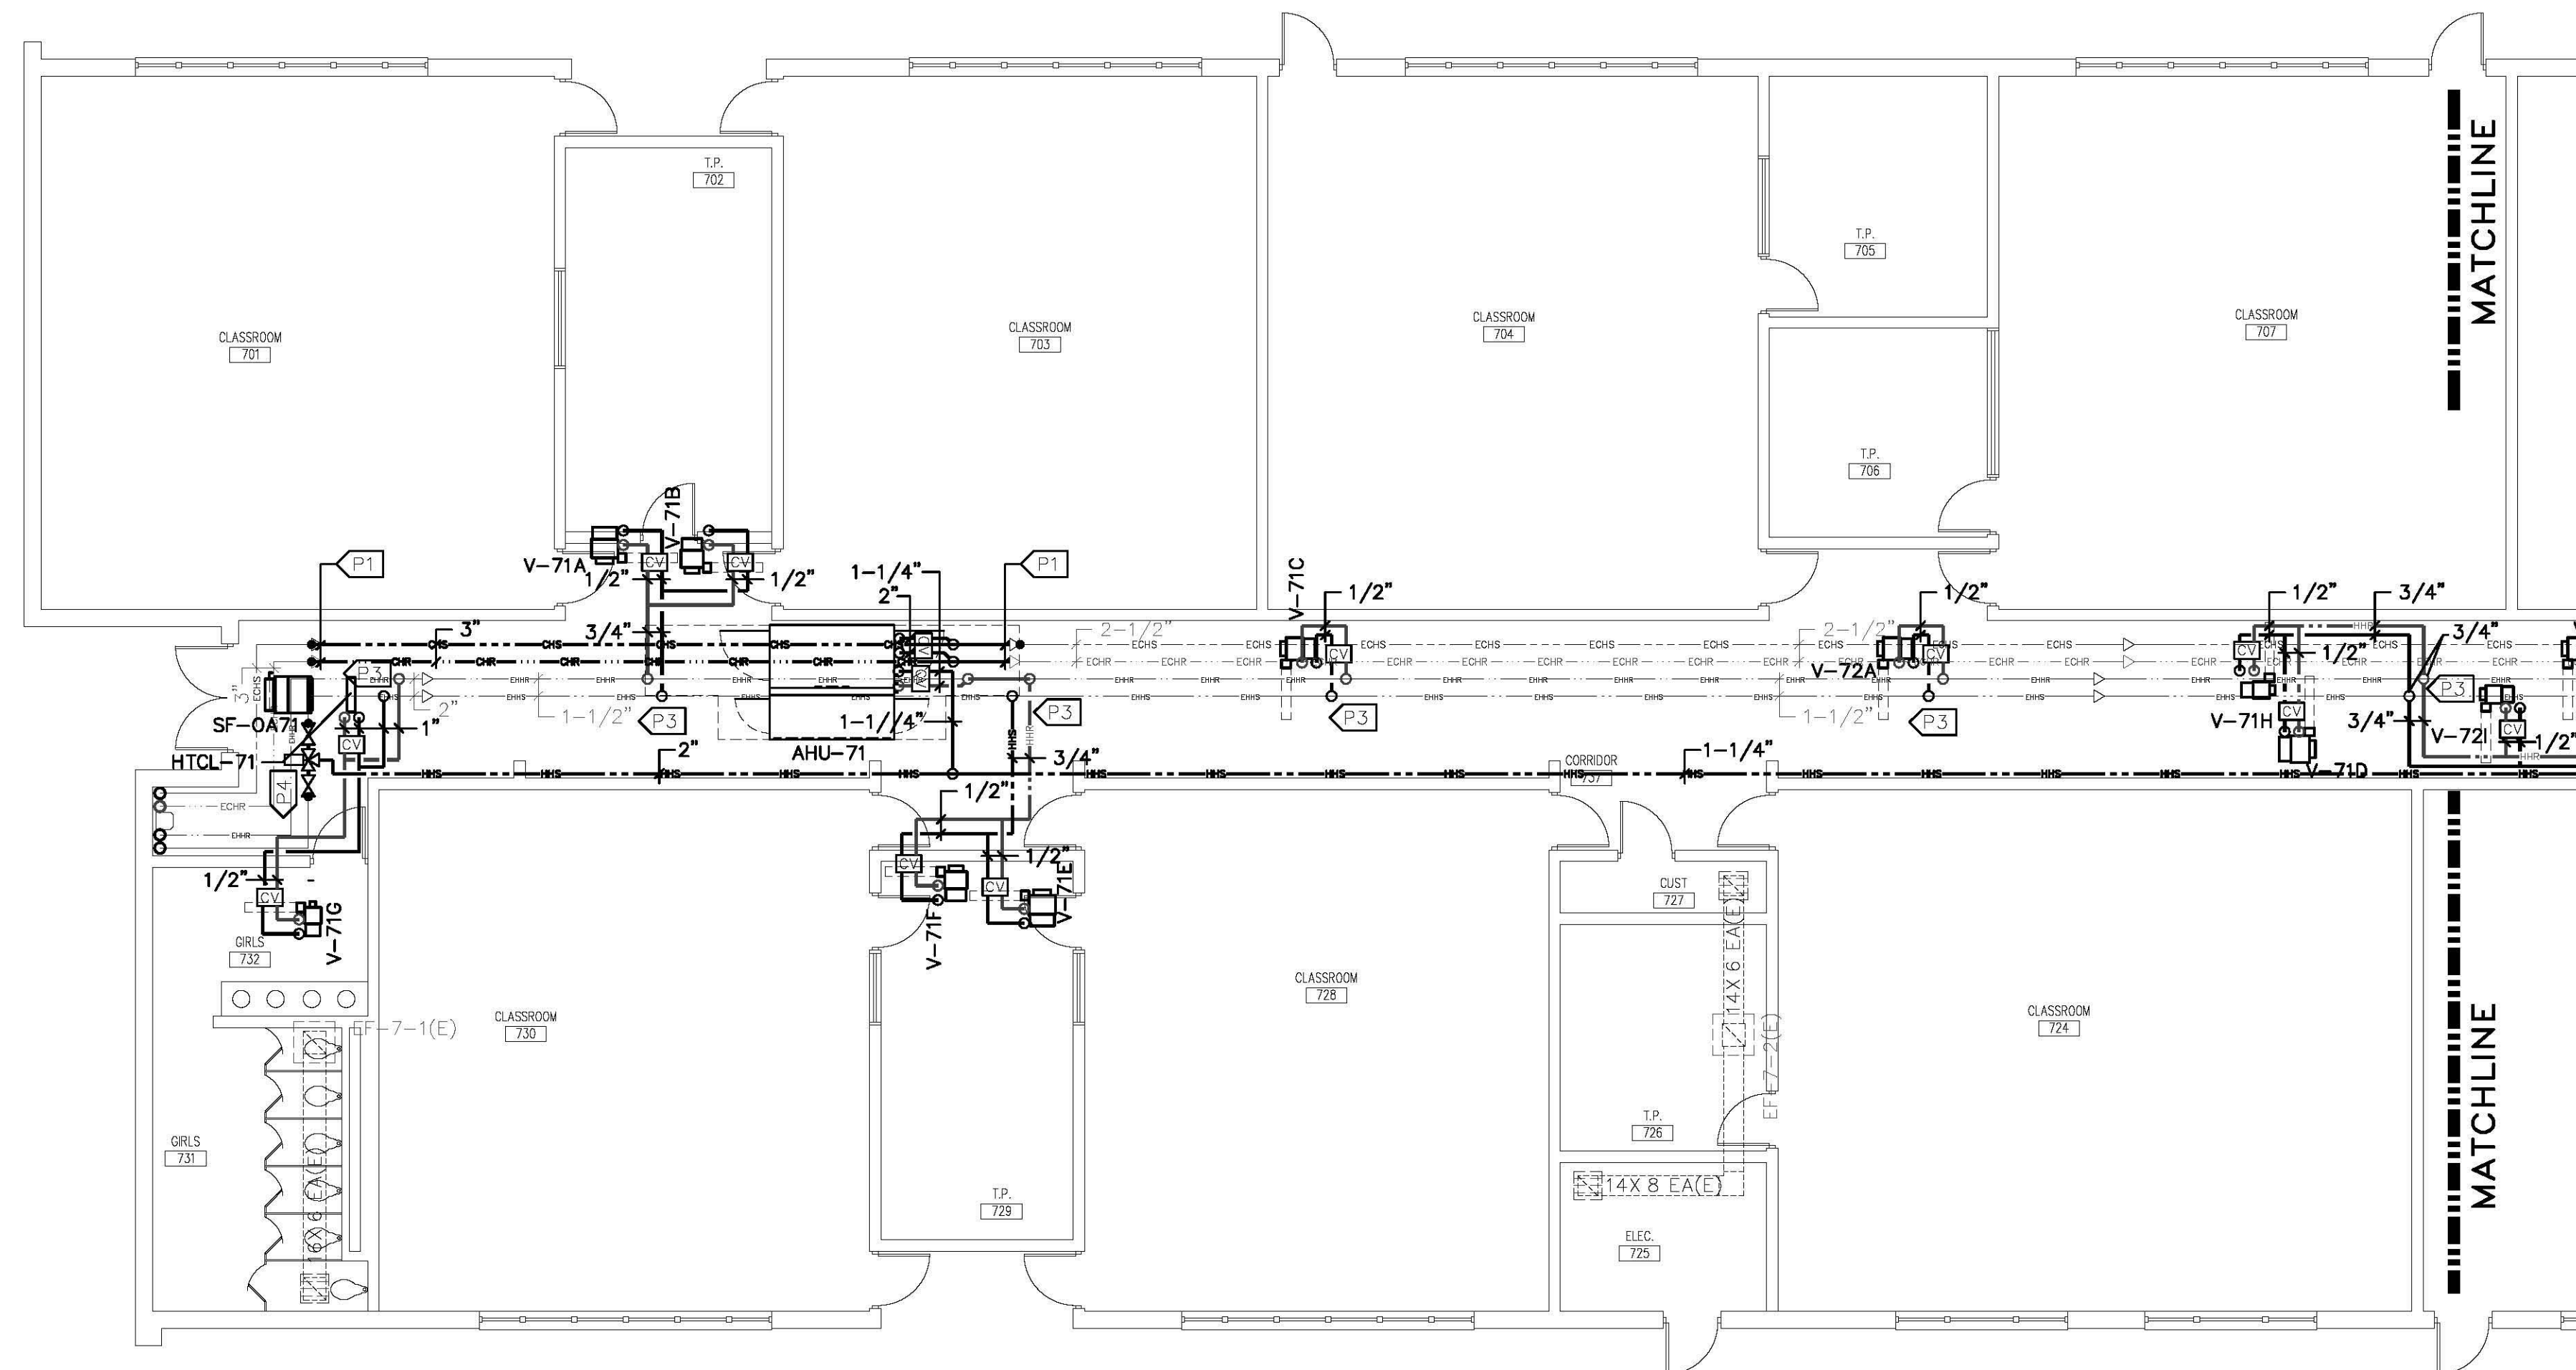


BLDG 7 PARTIAL PIPING PLAN "A"
 SCALE: 1/8" = 1'-0"

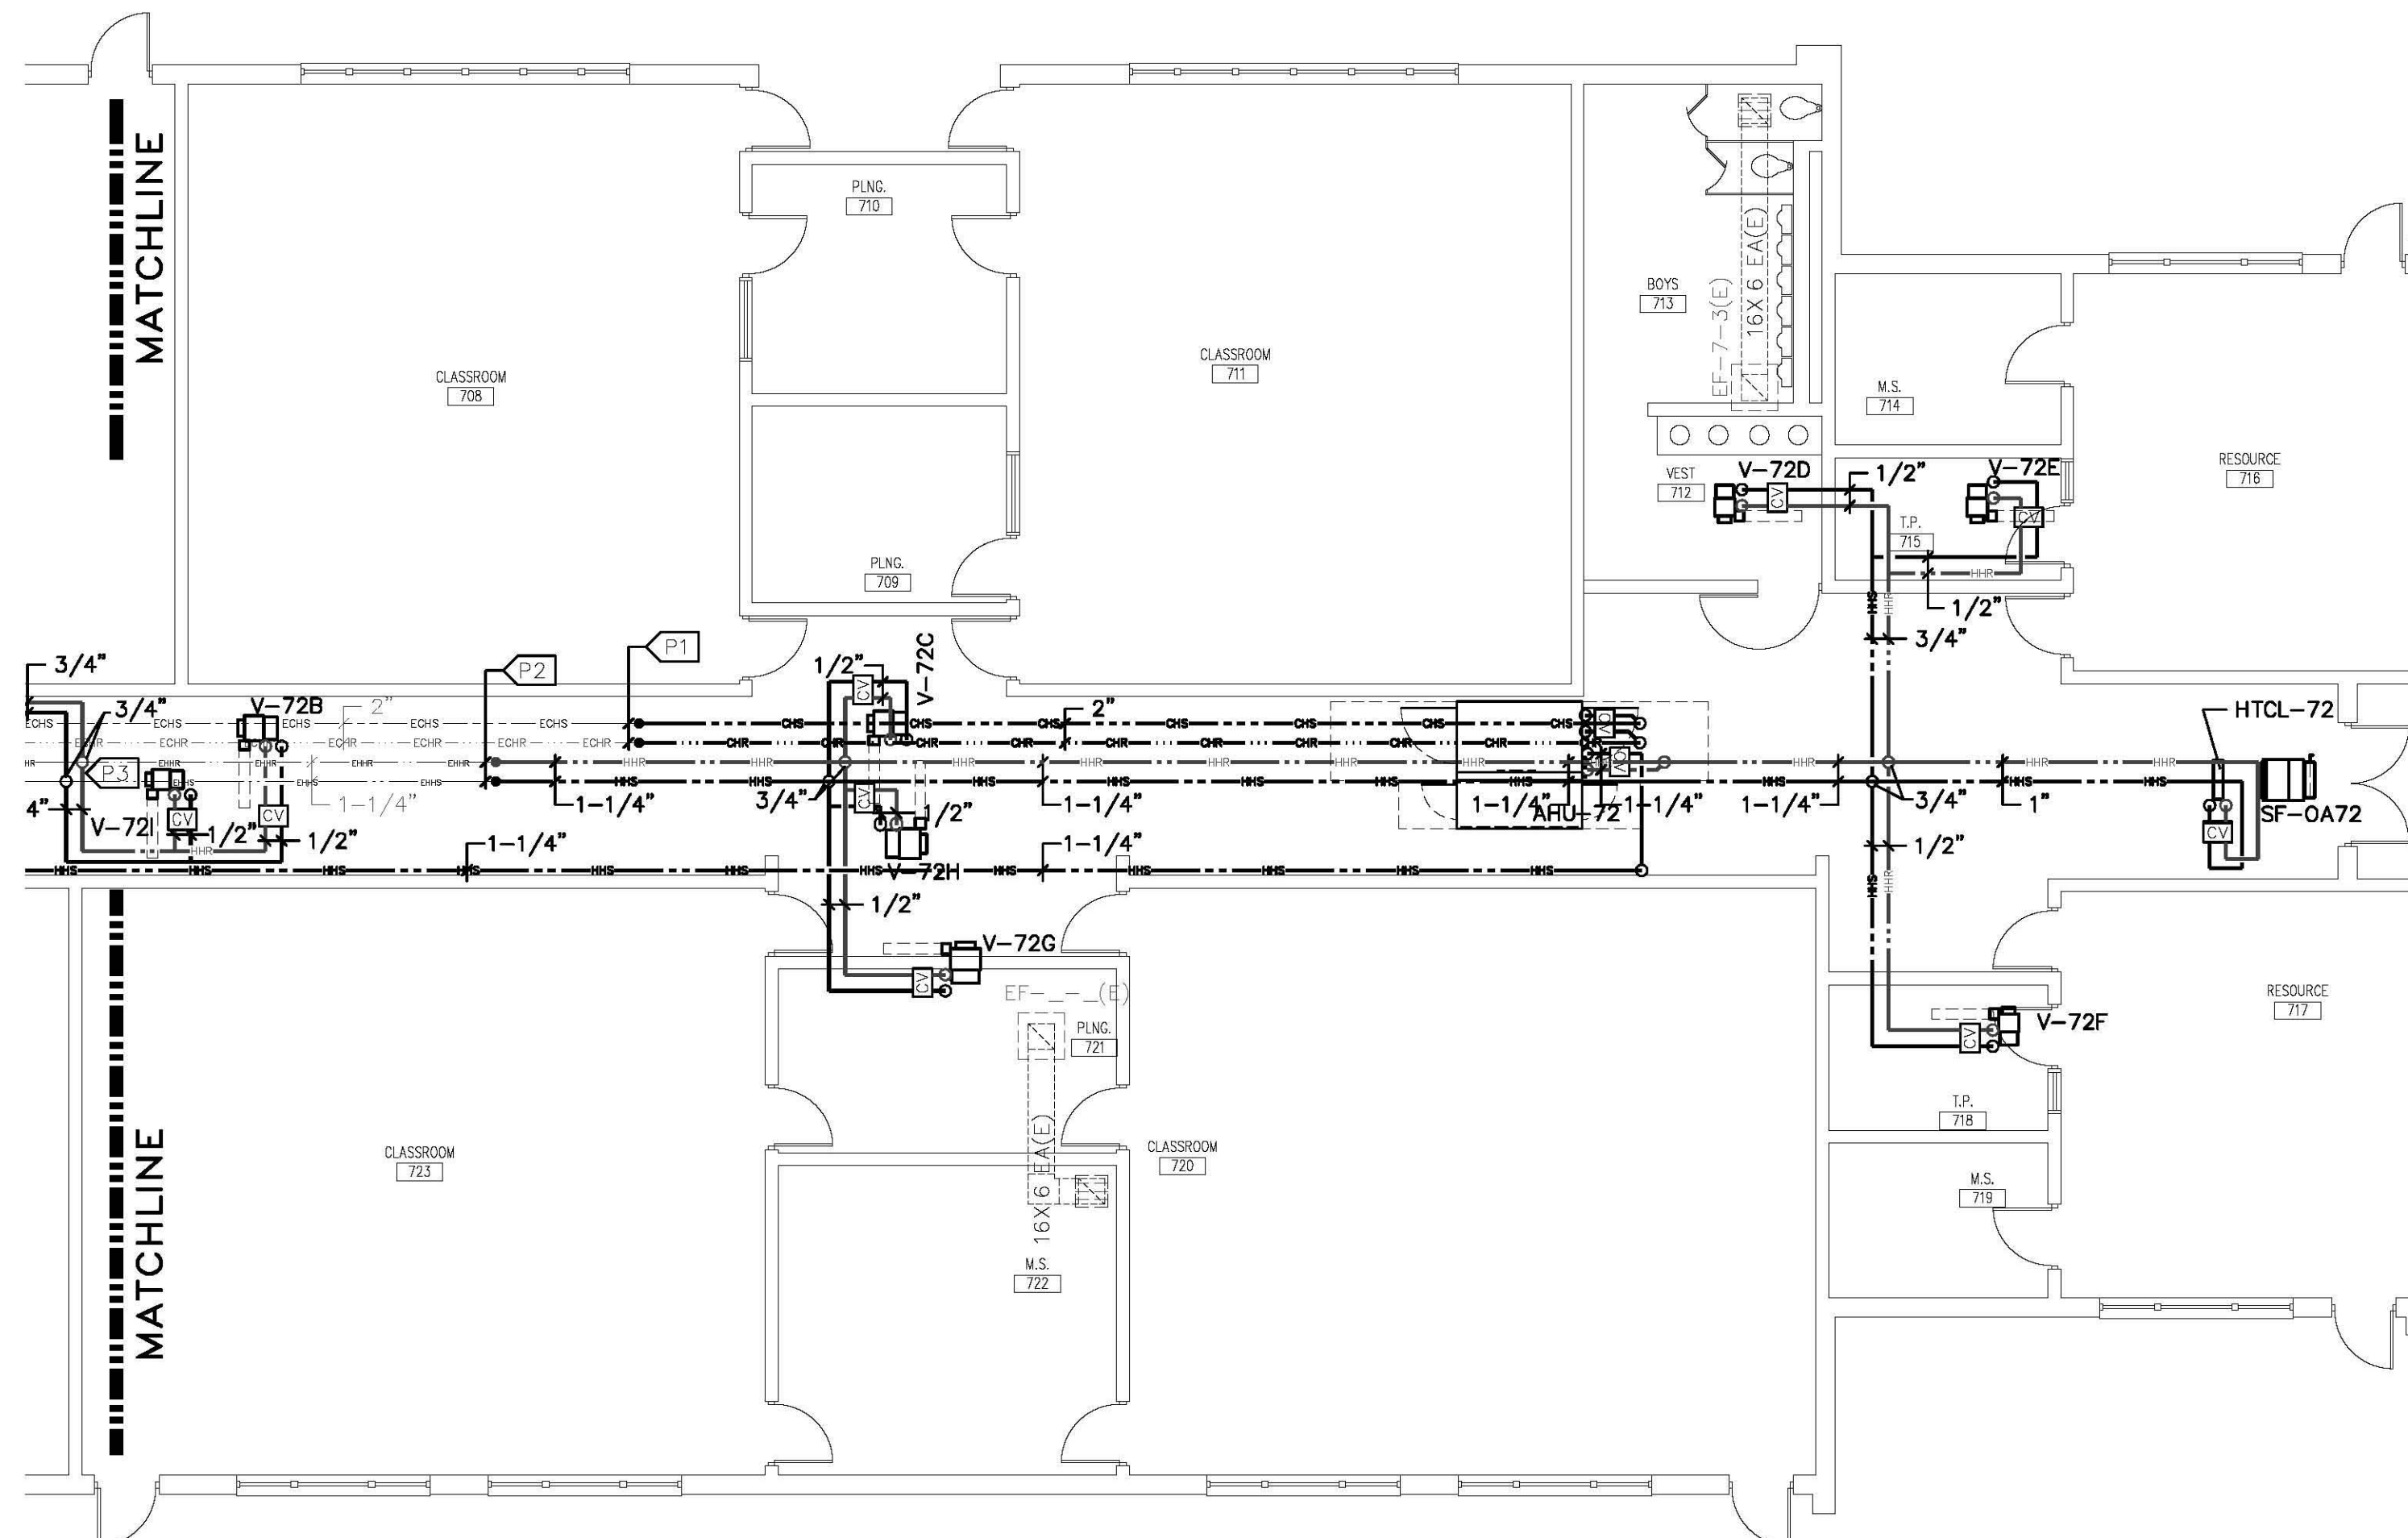


BLDG 7 PARTIAL PIPING PLAN "B"
 SCALE: 1/8" = 1'-0"

HVAC PIPING NOTES

-  DISCONNECT AND REMOVE EXISTING SECTIONS OF CHILLED WATER SUPPLY AND RETURN MAINS AND REPLACE WITH NEW SUPPLY AND RETURN PIPING WITH PIPE SIZES AS INDICATED ON THE DRAWING. CONNECT NEW PIPING TO EXISTING SUPPLY AND RETURN MAINS.
-  DISCONNECT AND REMOVE EXISTING HEATING HOT WATER SUPPLY AND RETURN MAINS AND REPLACE WITH NEW SUPPLY AND RETURN PIPING WITH PIPE SIZES AS INDICATED ON THE DRAWING. CONNECT NEW PIPING TO EXISTING SUPPLY AND RETURN MAINS.
-  CONNECT NEW PIPE TO EXISTING PIPE WITH NEW FITTING
-  INSTALL NEW SOLENOID VALVE ON EXISTING HEATING HOT WATER SUPPLY.

REVISIONS

POWELL & HINKLE ENGINEERING
 1409 KINGSLEY AVENUE, BLDG 12A
 ORANGE PARK, FLORIDA 32073
 (904) 264-5570 FAX: (904) 278-2646
 FLA. REG. # EB-0004577

SUWANNEE COUNTY MIDDLE SCHOOL
HVAC MODIFICATIONS – BUILDING 7
 LIVE OAK, FLORIDA

DATE: 2/17/12

SCALE: 1/8"

DRAWN: GCM

JOB: 1947

SHEET:

M-3

OF 6 SHEETS

FEB/15/12
 1947HVAC CWHWP M03